




LEGEND



- EXISTING POTABLE WATER WELL
- EXISTING MONITORING WELL
- EXISTING PIEZOMETER
- EXISTING BORING
- EXISTING ELECTRICAL TRANSFORMER
- EXISTING LIGHT POLE
- EXISTING TELEPHONE PEDESTAL
- EXISTING TELEPHONE HAND HOLE
- EXISTING CABLE TV BOX
- EXISTING POTABLE WATER METER
- EXISTING POTABLE WATER TREATMENT BACKWASH FORCEMAIN
- EXISTING FORCEMAIN
- EXISTING POTABLE WATER
- EXISTING SANITARY SEWER
- EXISTING FENCE
- EXISTING MINOR CONTOUR
- EXISTING MAJOR CONTOUR
- EXISTING STREAM
- EXISTING PROPERTY LINE
- EXISTING OVERHEAD ELECTRIC
- EXISTING STORM DRAIN
- EXISTING BUSHES
- EXISTING WOODSLINE
- EXISTING RIP RAP AREA
- EXISTING LANDSCAPED AREA
- EXISTING WETLAND AREA

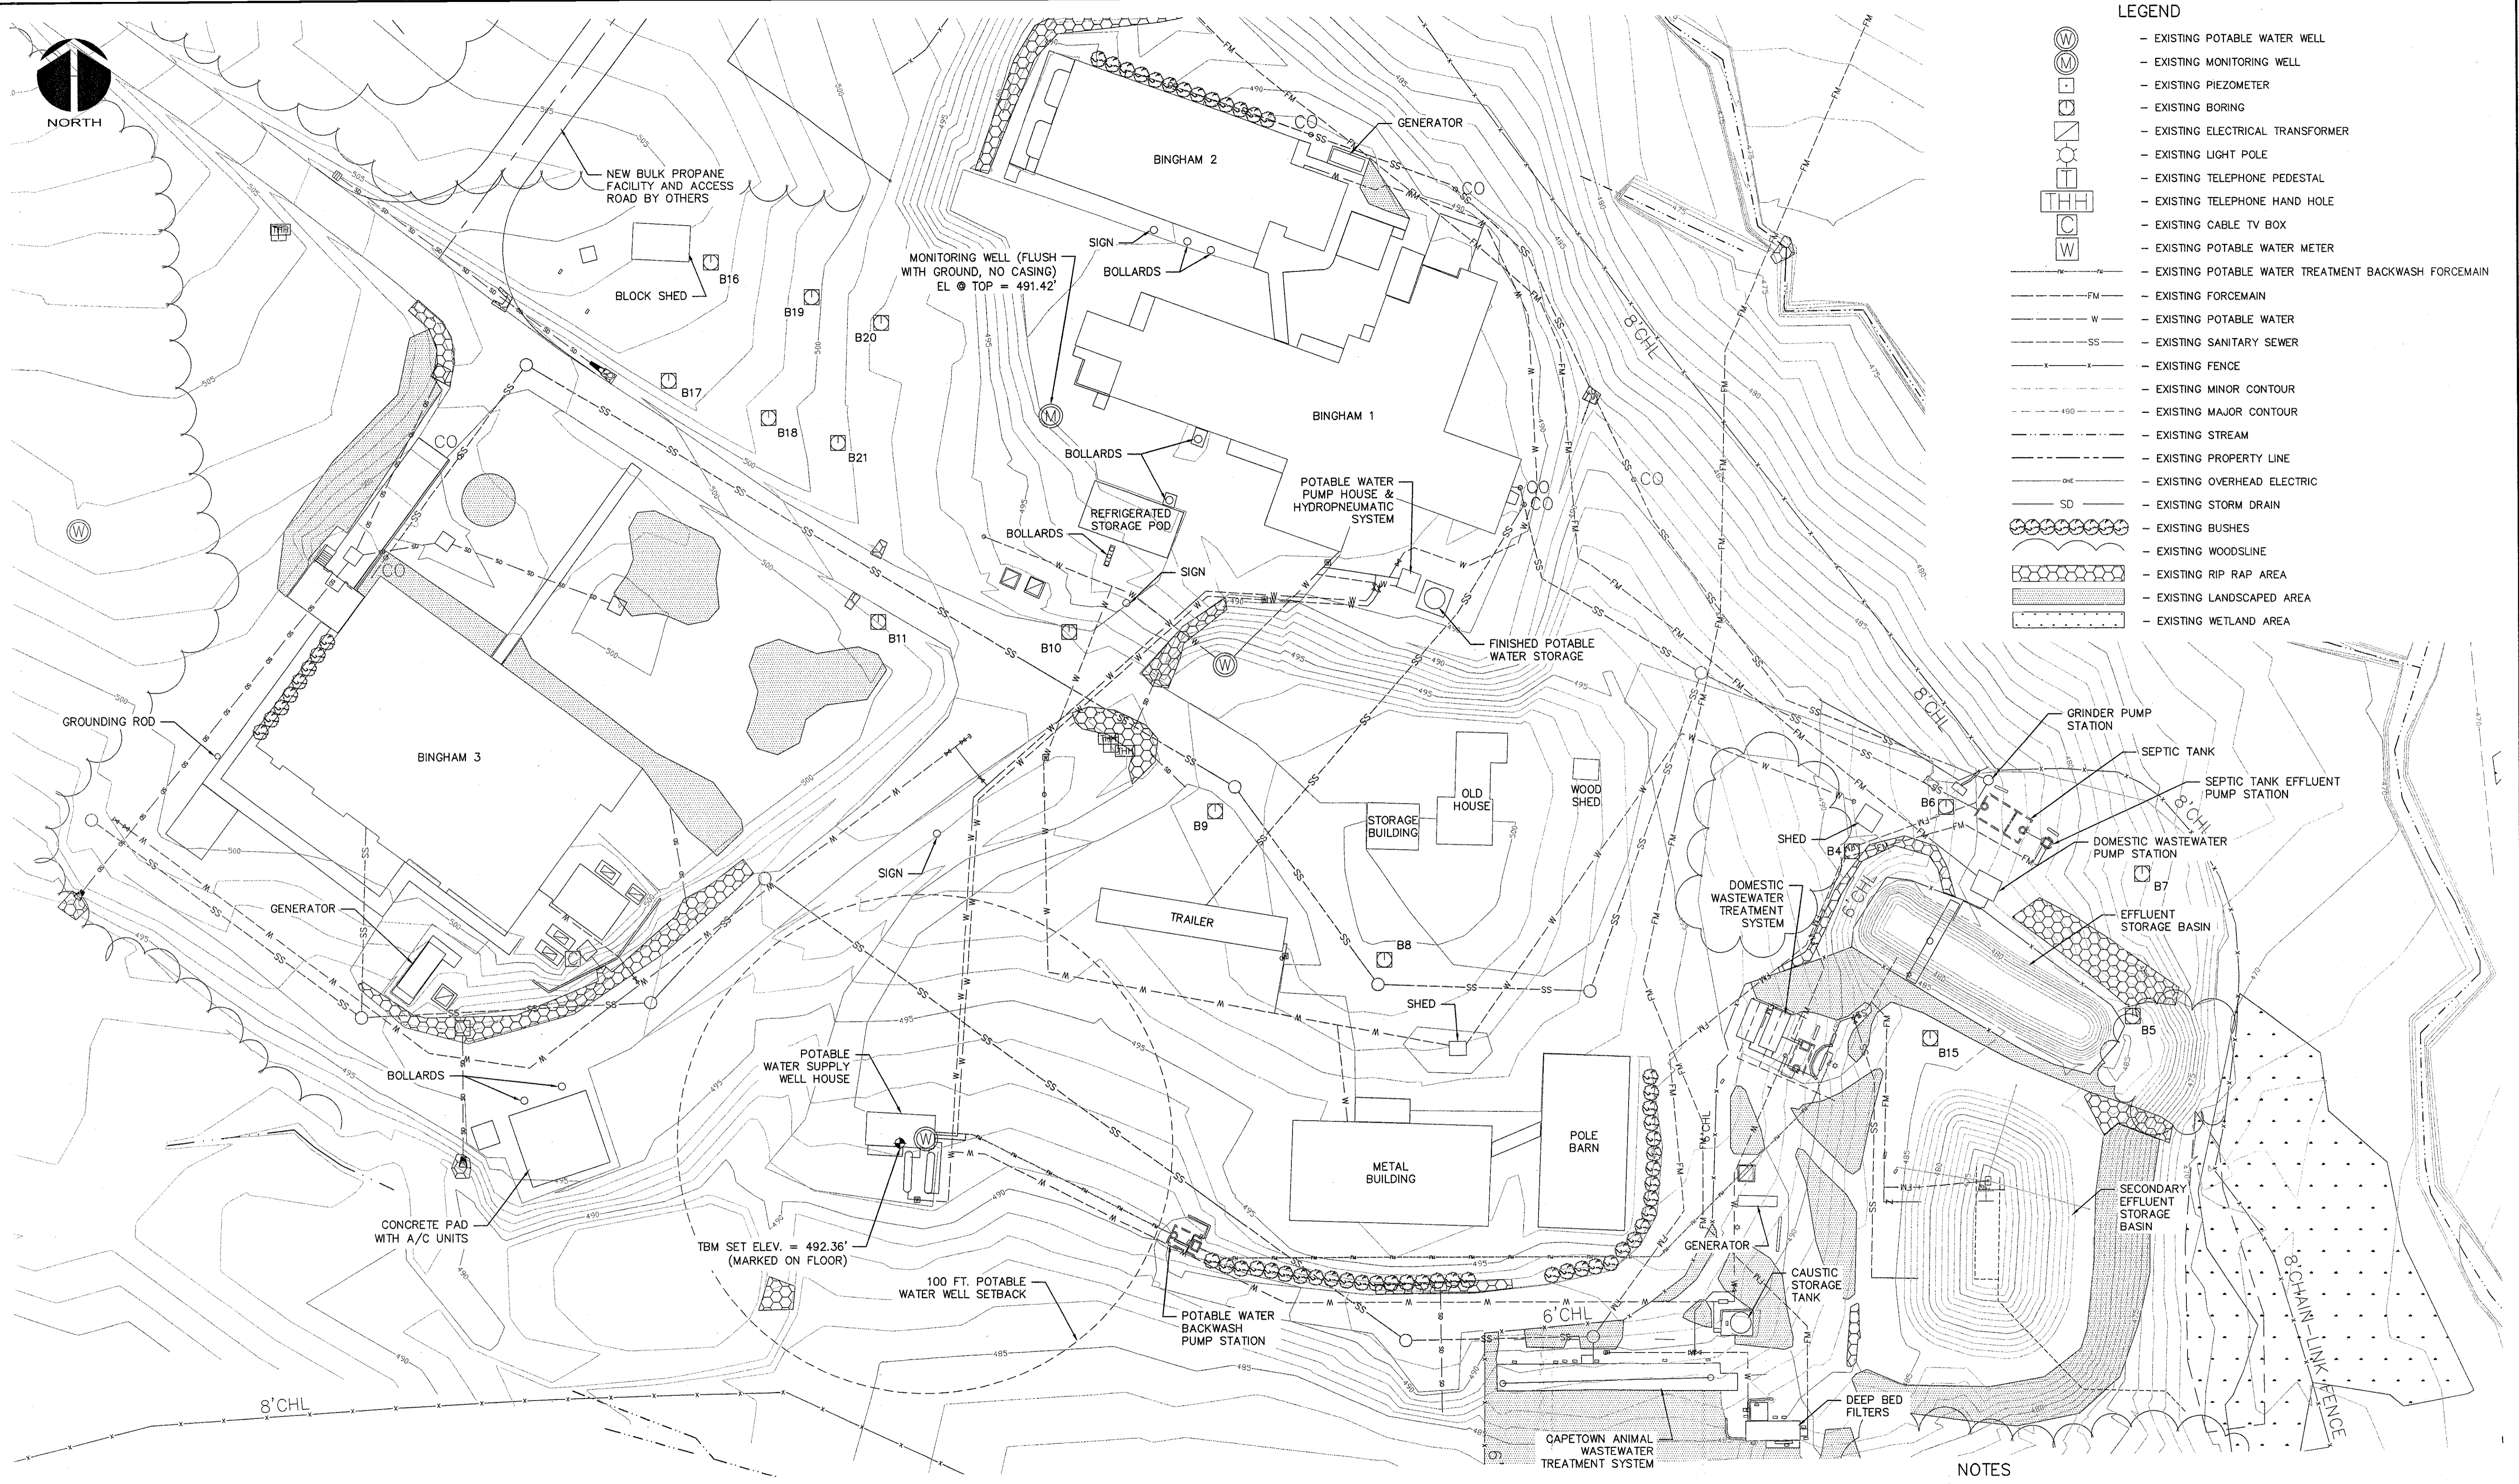

EXISTING ENLARGED SITE PLAN  
SCALE: 1" = 30'

- NOTES
- EXISTING UNDERGROUND UTILITIES ARE SHOWN BASED ON BEST AVAILABLE INFORMATION AT THE TIME OF DESIGN. IT IS THE CONTRACTOR'S RESPONSIBILITY TO LOCATE ALL EXISTING UTILITIES BEFORE PERFORMING WORK.
  - REFERENCE ELECTRICAL DRAWINGS FOR EXISTING UNDERGROUND ELECTRICAL UTILITIES.

REV. NO.	DESCRIPTIONS	DATE
D	FINAL DESIGN - NOT RELEASED FOR CONSTRUCTION	8/11/11
C	FINAL DESIGN SUBMITTAL	7/28/11
B	85% DESIGN SUBMITTAL	4/18/11
A	60% DESIGN SUBMITTAL	5/21/11

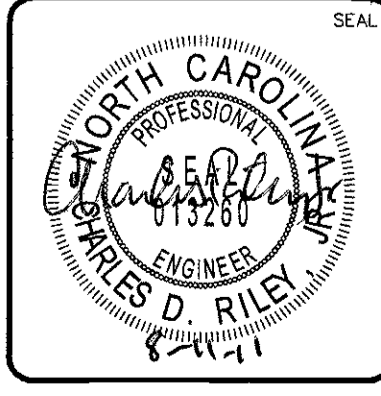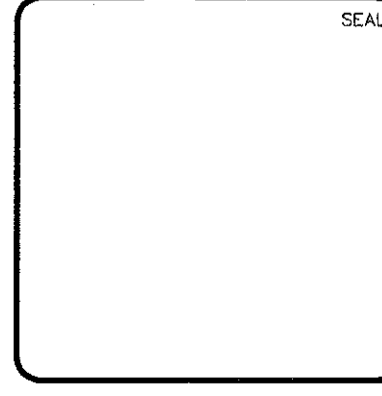

**MCKIM & CREED**  
 1730 Varsity Drive, Suite 500  
 Raleigh, North Carolina 27606  
 Phone: (919)233-8091, Fax: (919)233-8031  
 License: F-1222  
 www.mckimcreed.com

**THE UNIVERSITY  
 of NORTH CAROLINA  
 at CHAPEL HILL**

**BINGHAM FACILITY  
 WASTEWATER SYSTEM IMPROVEMENTS**  
 EXISTING ENLARGED SITE PLAN

DATE: FEBRUARY 2011	SCALE: HORIZONTAL: 1" = 30'	VERTICAL: NA	MAC FILE NUMBER: C02
MCE PROJ. # 1488-0032	DRAWN: SHK	DESIGNED: CDR	CHECKED: CDR
PROJ. MGR: CDR	STATUS: FINAL DESIGN - NOT RELEASED FOR CONSTRUCTION		

Published in Build